


**BEAUTIFICATION OF  
DURGIANA MANDIR COMPLEX  
AMRITSAR  
(PROPOSED PARKING )**

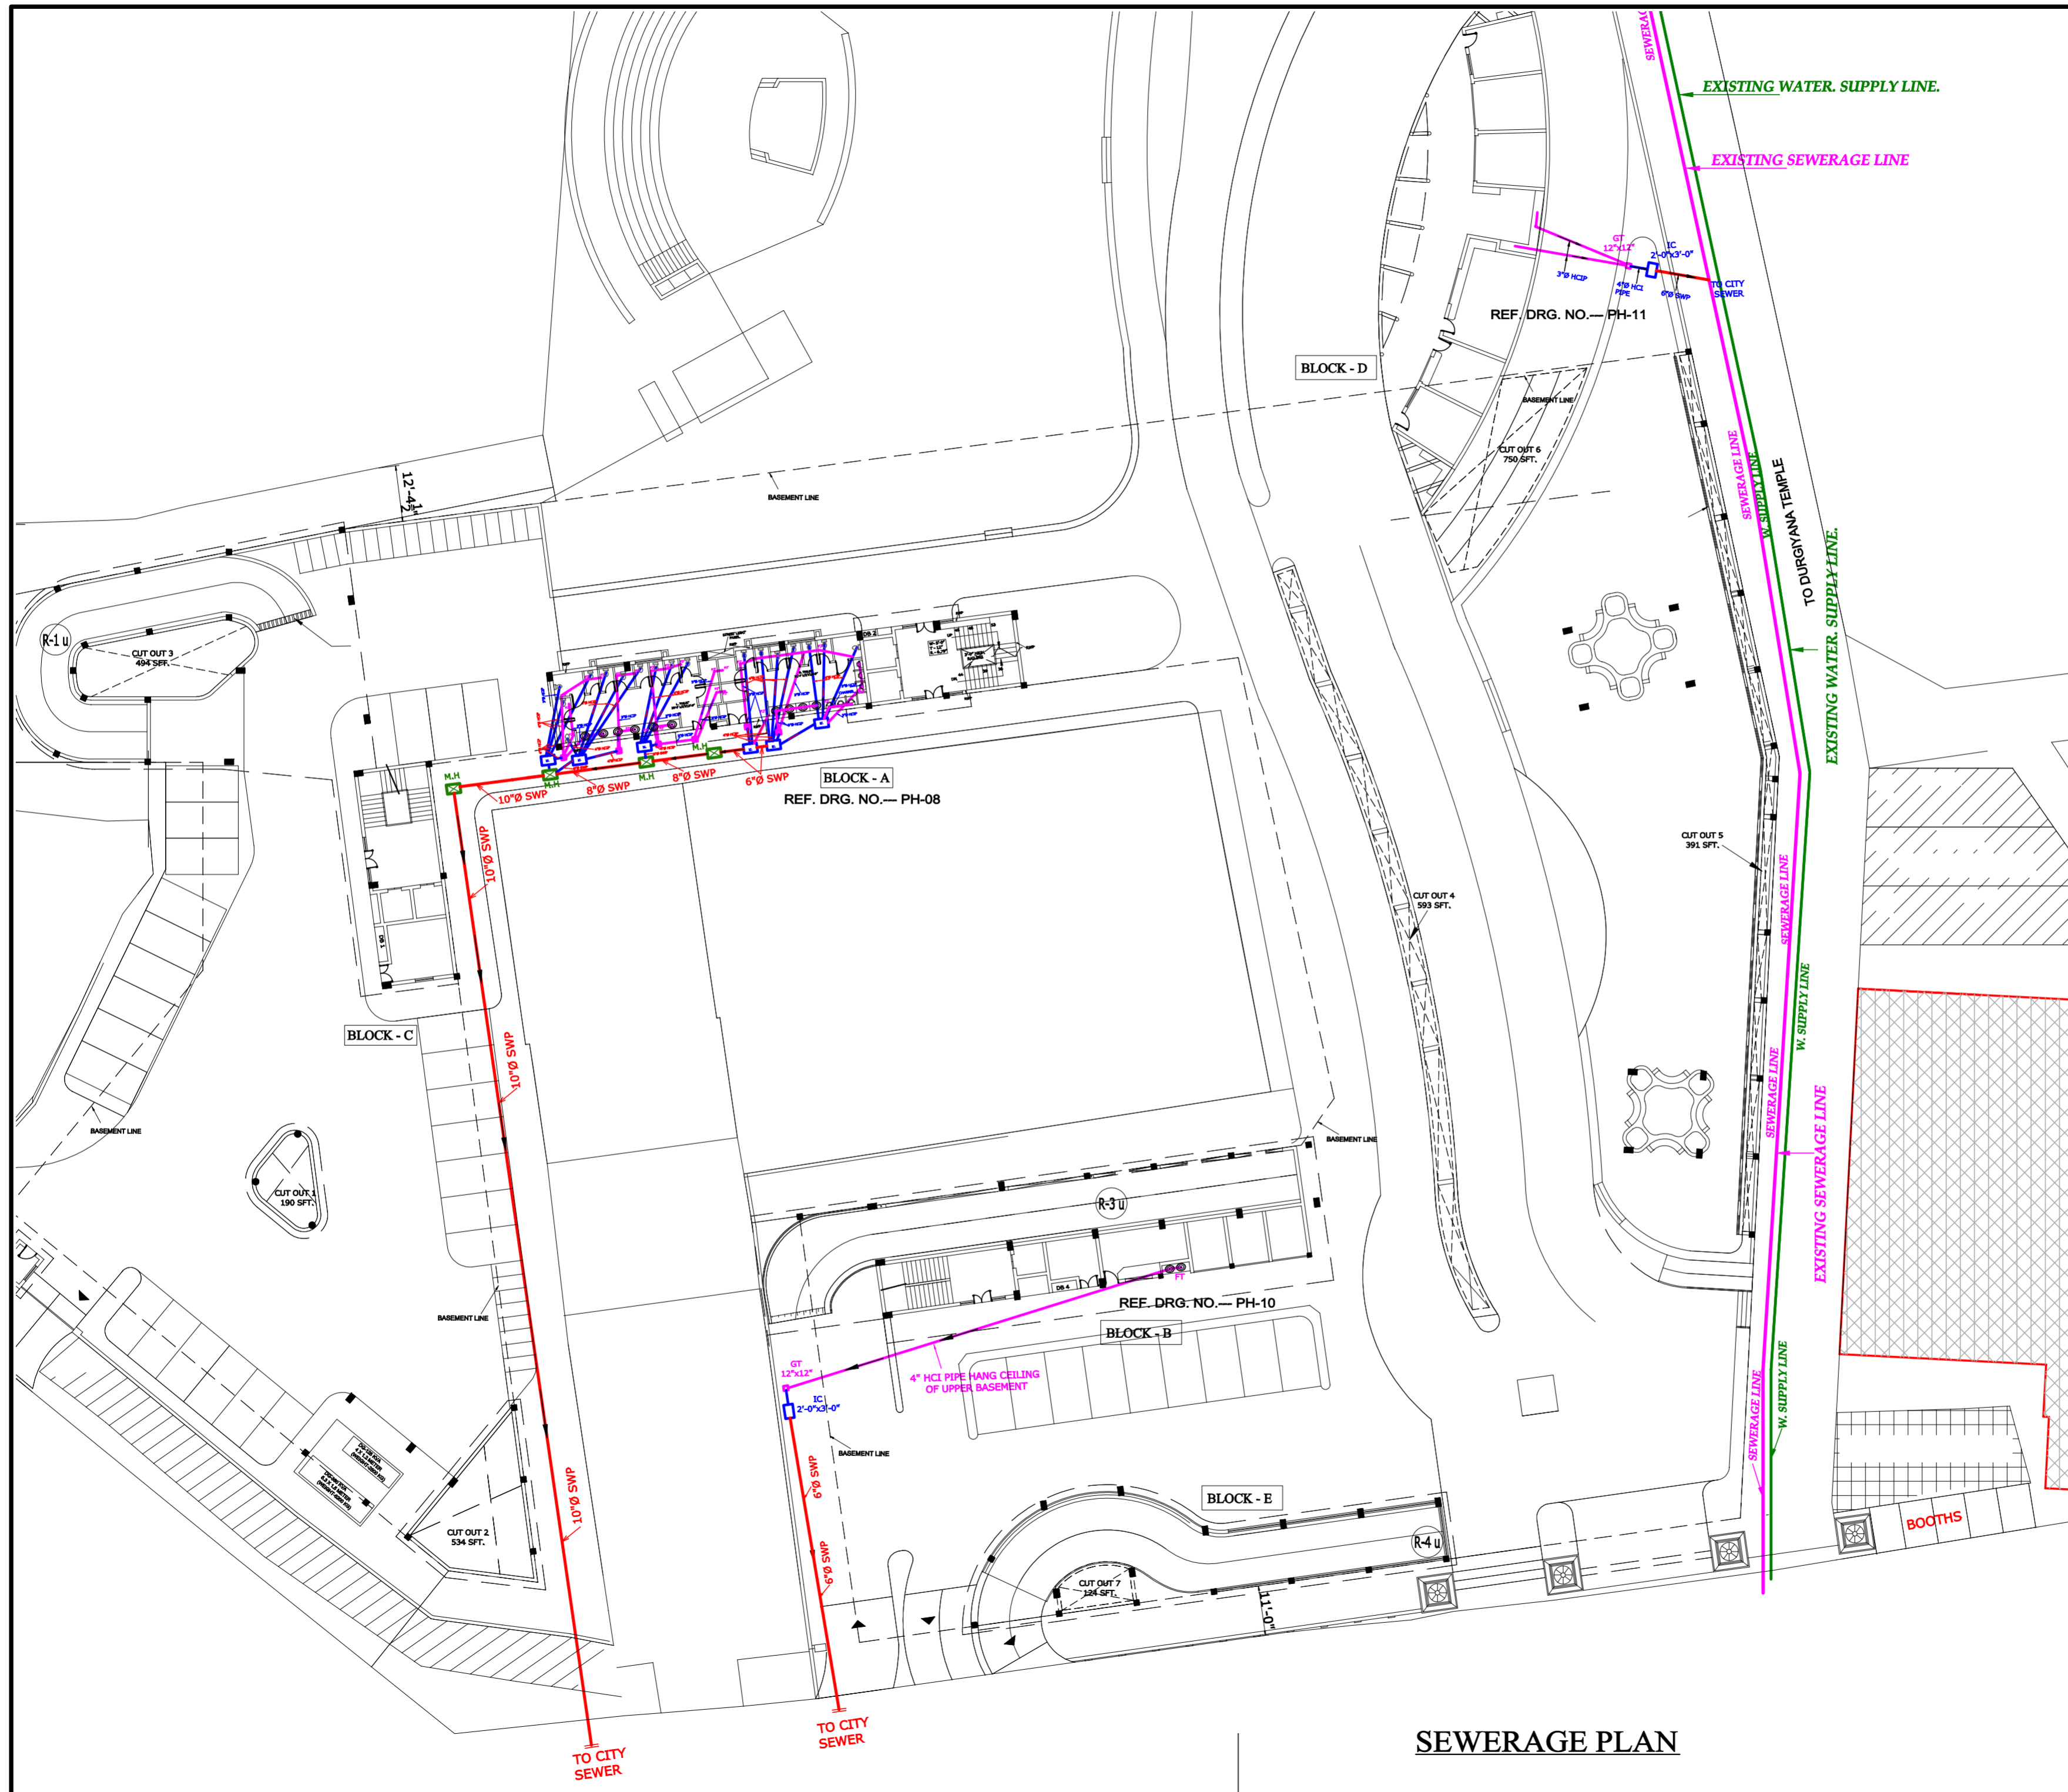

**SEWERAGE PLAN**

OWNER :

PUBLIC HEALTH CONSULTANT :-  
  
HARBANS SINGH  
Public Health Engineer (Rtd.)

DRAWING TITLE	
SITE PLAN SEWERAGE PLAN	
DRAWING NO.	DRAWN BY
A-02	
PROJ. NO. :-	CHKD. BY
0967	SHARDA PAL
SCALE:	DATE
	23.01.13

**ARCHITECTS CONSORTIUM**  
ARCHITECTS, PLANNERS, ENGINEERS,  
INTERIOR & INDUSTRIAL DESIGNERS  
S.C.O - 42, PHASE-3B2, MOHALI. (Pb.).  
☎ - 0172-5093132; ☎ - 0172-4643132;  
☎ - 98154 43132.  
E-mail - info@sudvivek.com  
Web site :- www.sudvivek.com

© COPYRIGHT