


**BEAUTIFICATION OF  
DURGIANA MANDIR COMPLEX  
AMRITSAR  
(PROPOSED PARKING )**

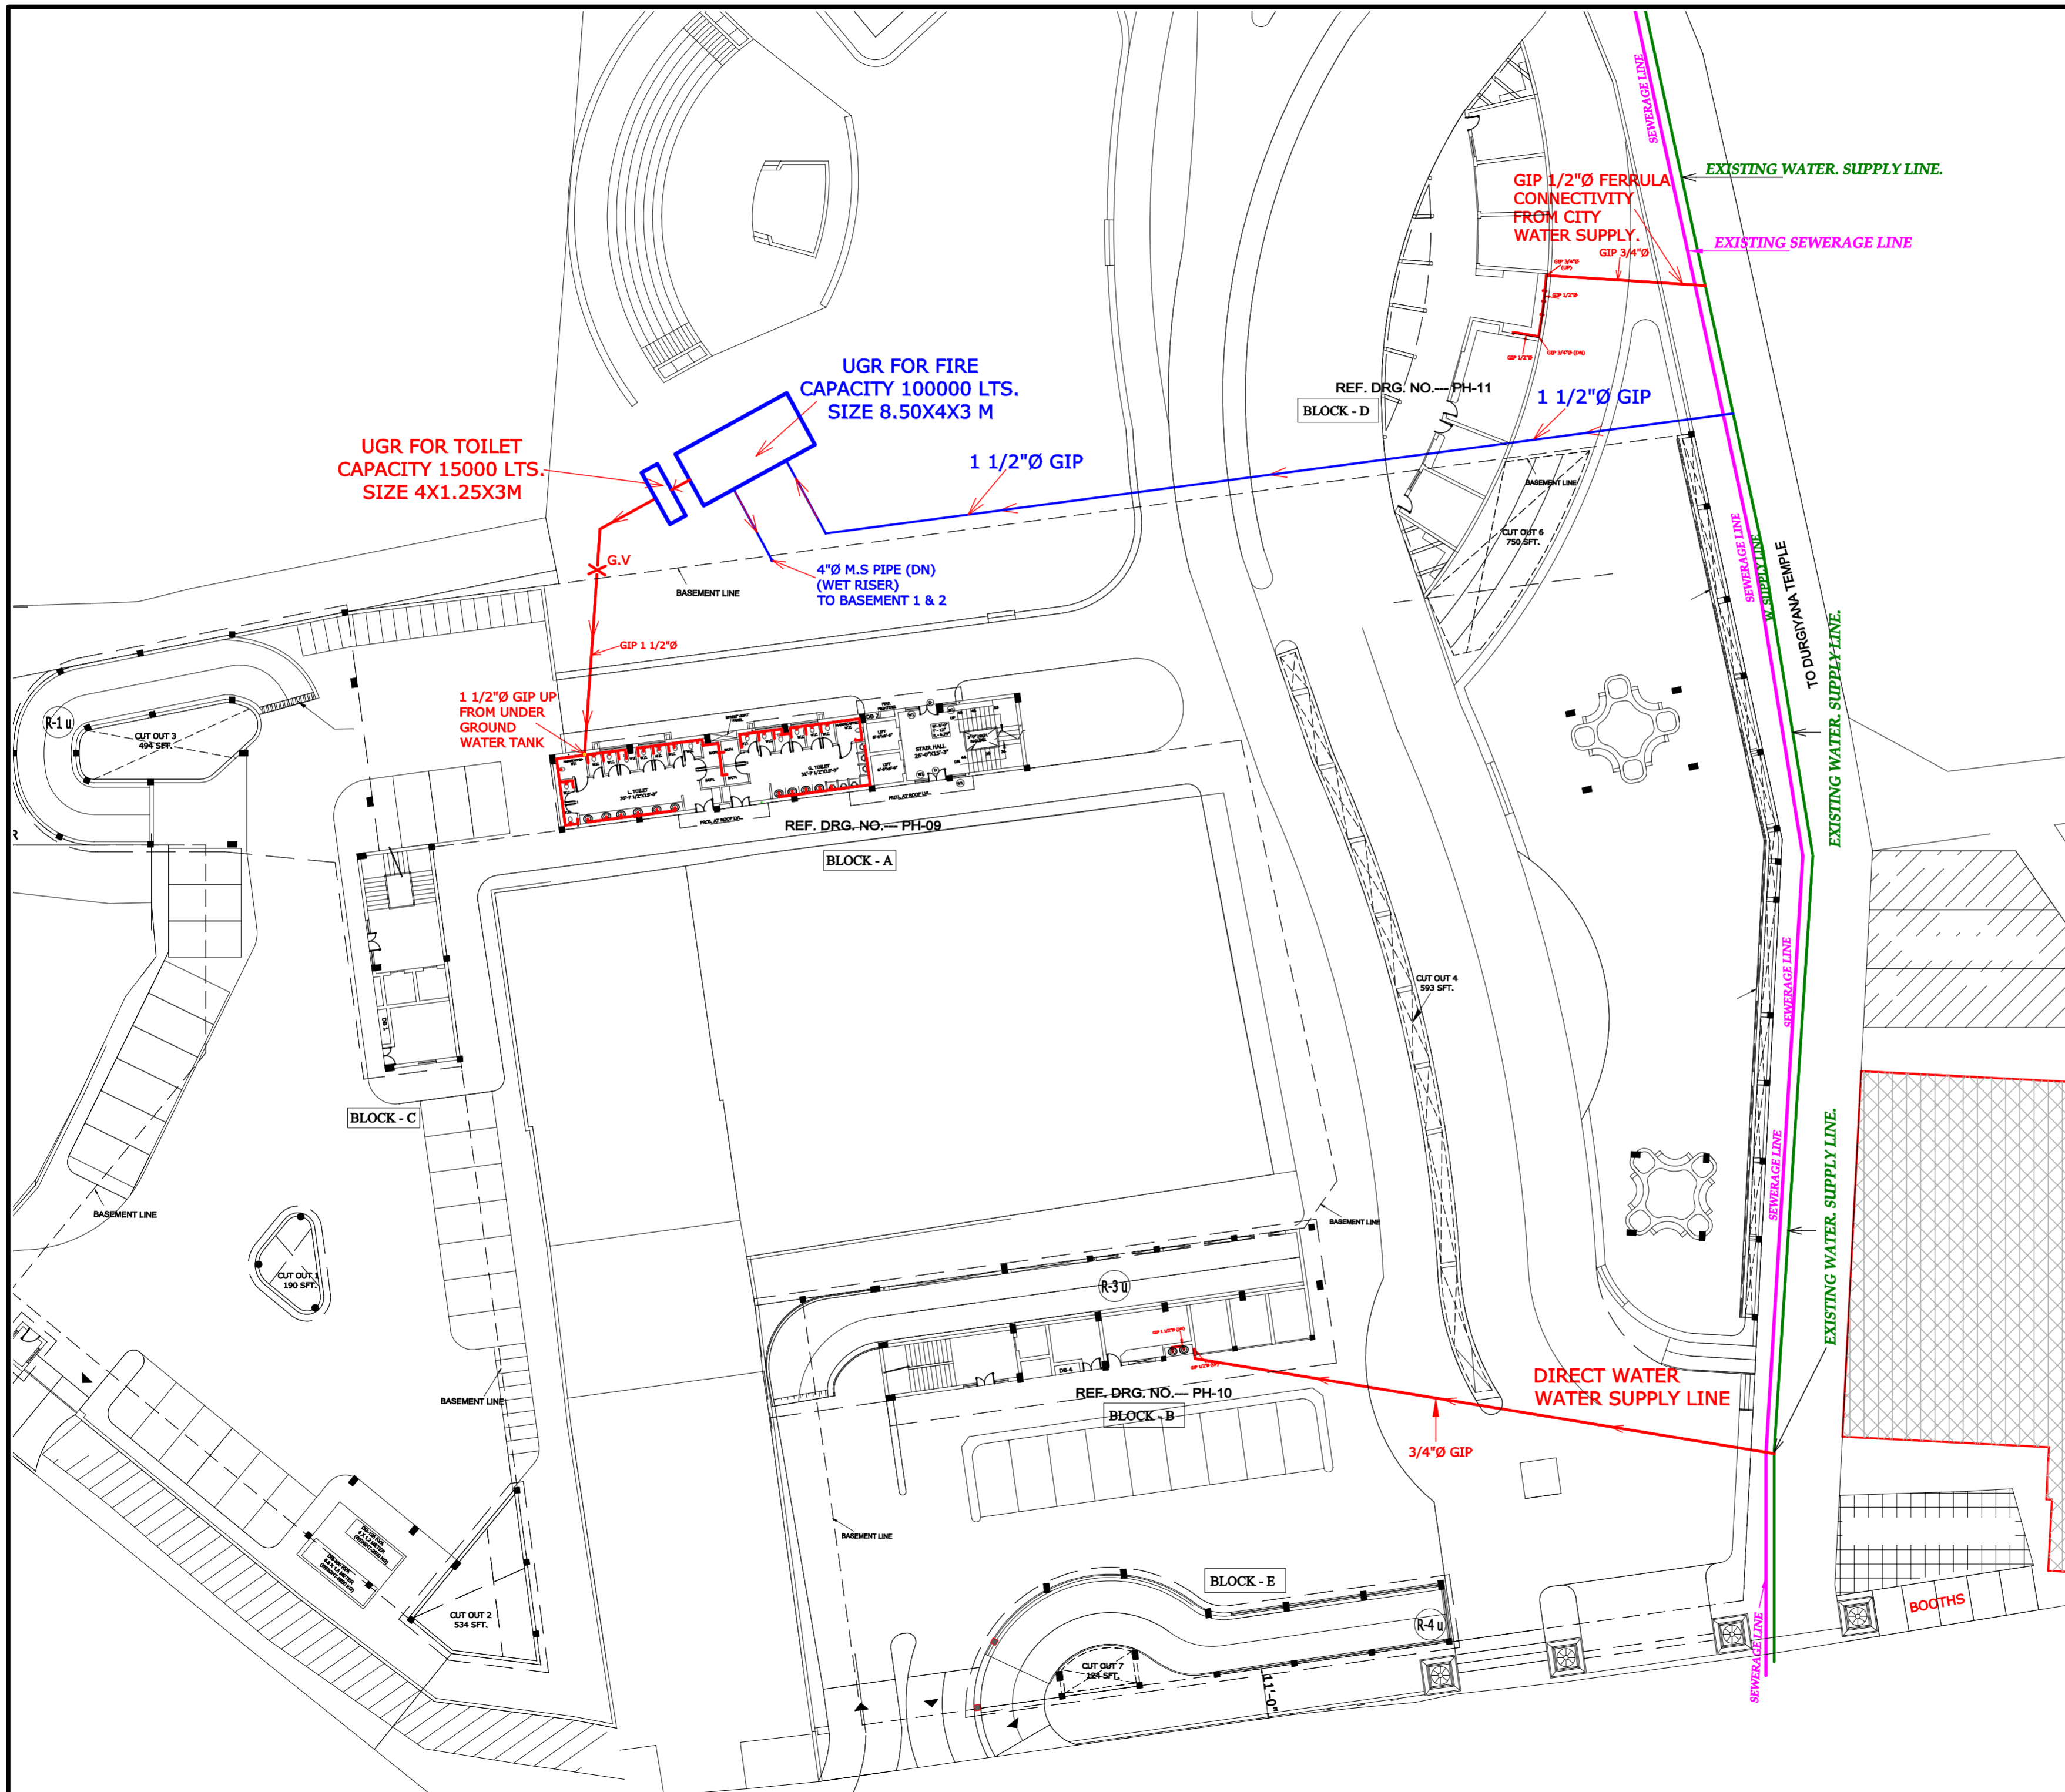

OWNER :

PUBLIC HEALTH CONSULTANT :-

HARBANS SINGH  
Public Health Engineer (Rtd.)

DRAWING TITLE		SITE PLAN	
		WATER SUPPLY PLAN	
DRAWING NO.	A-03	DRAWN BY	
PROJ.NO. :-	0967	CHKD. BY	SHARDA PAL
SCALE:		DATE	06.12.2013

**ARCHITECTS CONSORTIUM**

ARCHITECTS, PLANNERS, ENGINEERS,  
INTERIOR & INDUSTRIAL DESIGNERS  
S.C.O - 42, PHASE-3B2, MOHALI. (Pb.)  
☎ - 0172-5093132; ☎ - 0172-4643132;  
☎ - 98154 43132.  
E-mail - info@sudvivek.com  
Web site :- www.sudvivek.com

