

**BEAUTIFICATION OF
DURGIANA MANDIR COMPLEX
AMRITSAR
(PROPOSED PARKING)**

OWNER :

PUBLIC HEALTH CONSULTANT :-


HARBANS SINGH
Public Health Engineer (Rtd.)

DRAWING TITLE

UPPER BASEMENT DRAIN PLAN

DRAWING NO.	PH - 05	DRAWN BY	SEEMA
PROJ.NO.	0967	CHKD. BY	SHARDA PAL
SCALE.		DATE	08.01.2013

ARCHITECTS CONSORTIUM

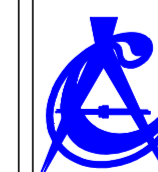

ARCHITECTS, PLANNERS, ENGINEERS,
INTERIOR & INDUSTRIAL DESIGNERS
S.C.O - 42, PHASE-3B2, MOHALI, (Pb.).


☎ - 0172-5093132; ☎ - 0172-4643132;

☎ - 98154 43132.

E-mail - info@sudvivek.com

Web site :- www.sudvivek.com

©
COPYRIGHT

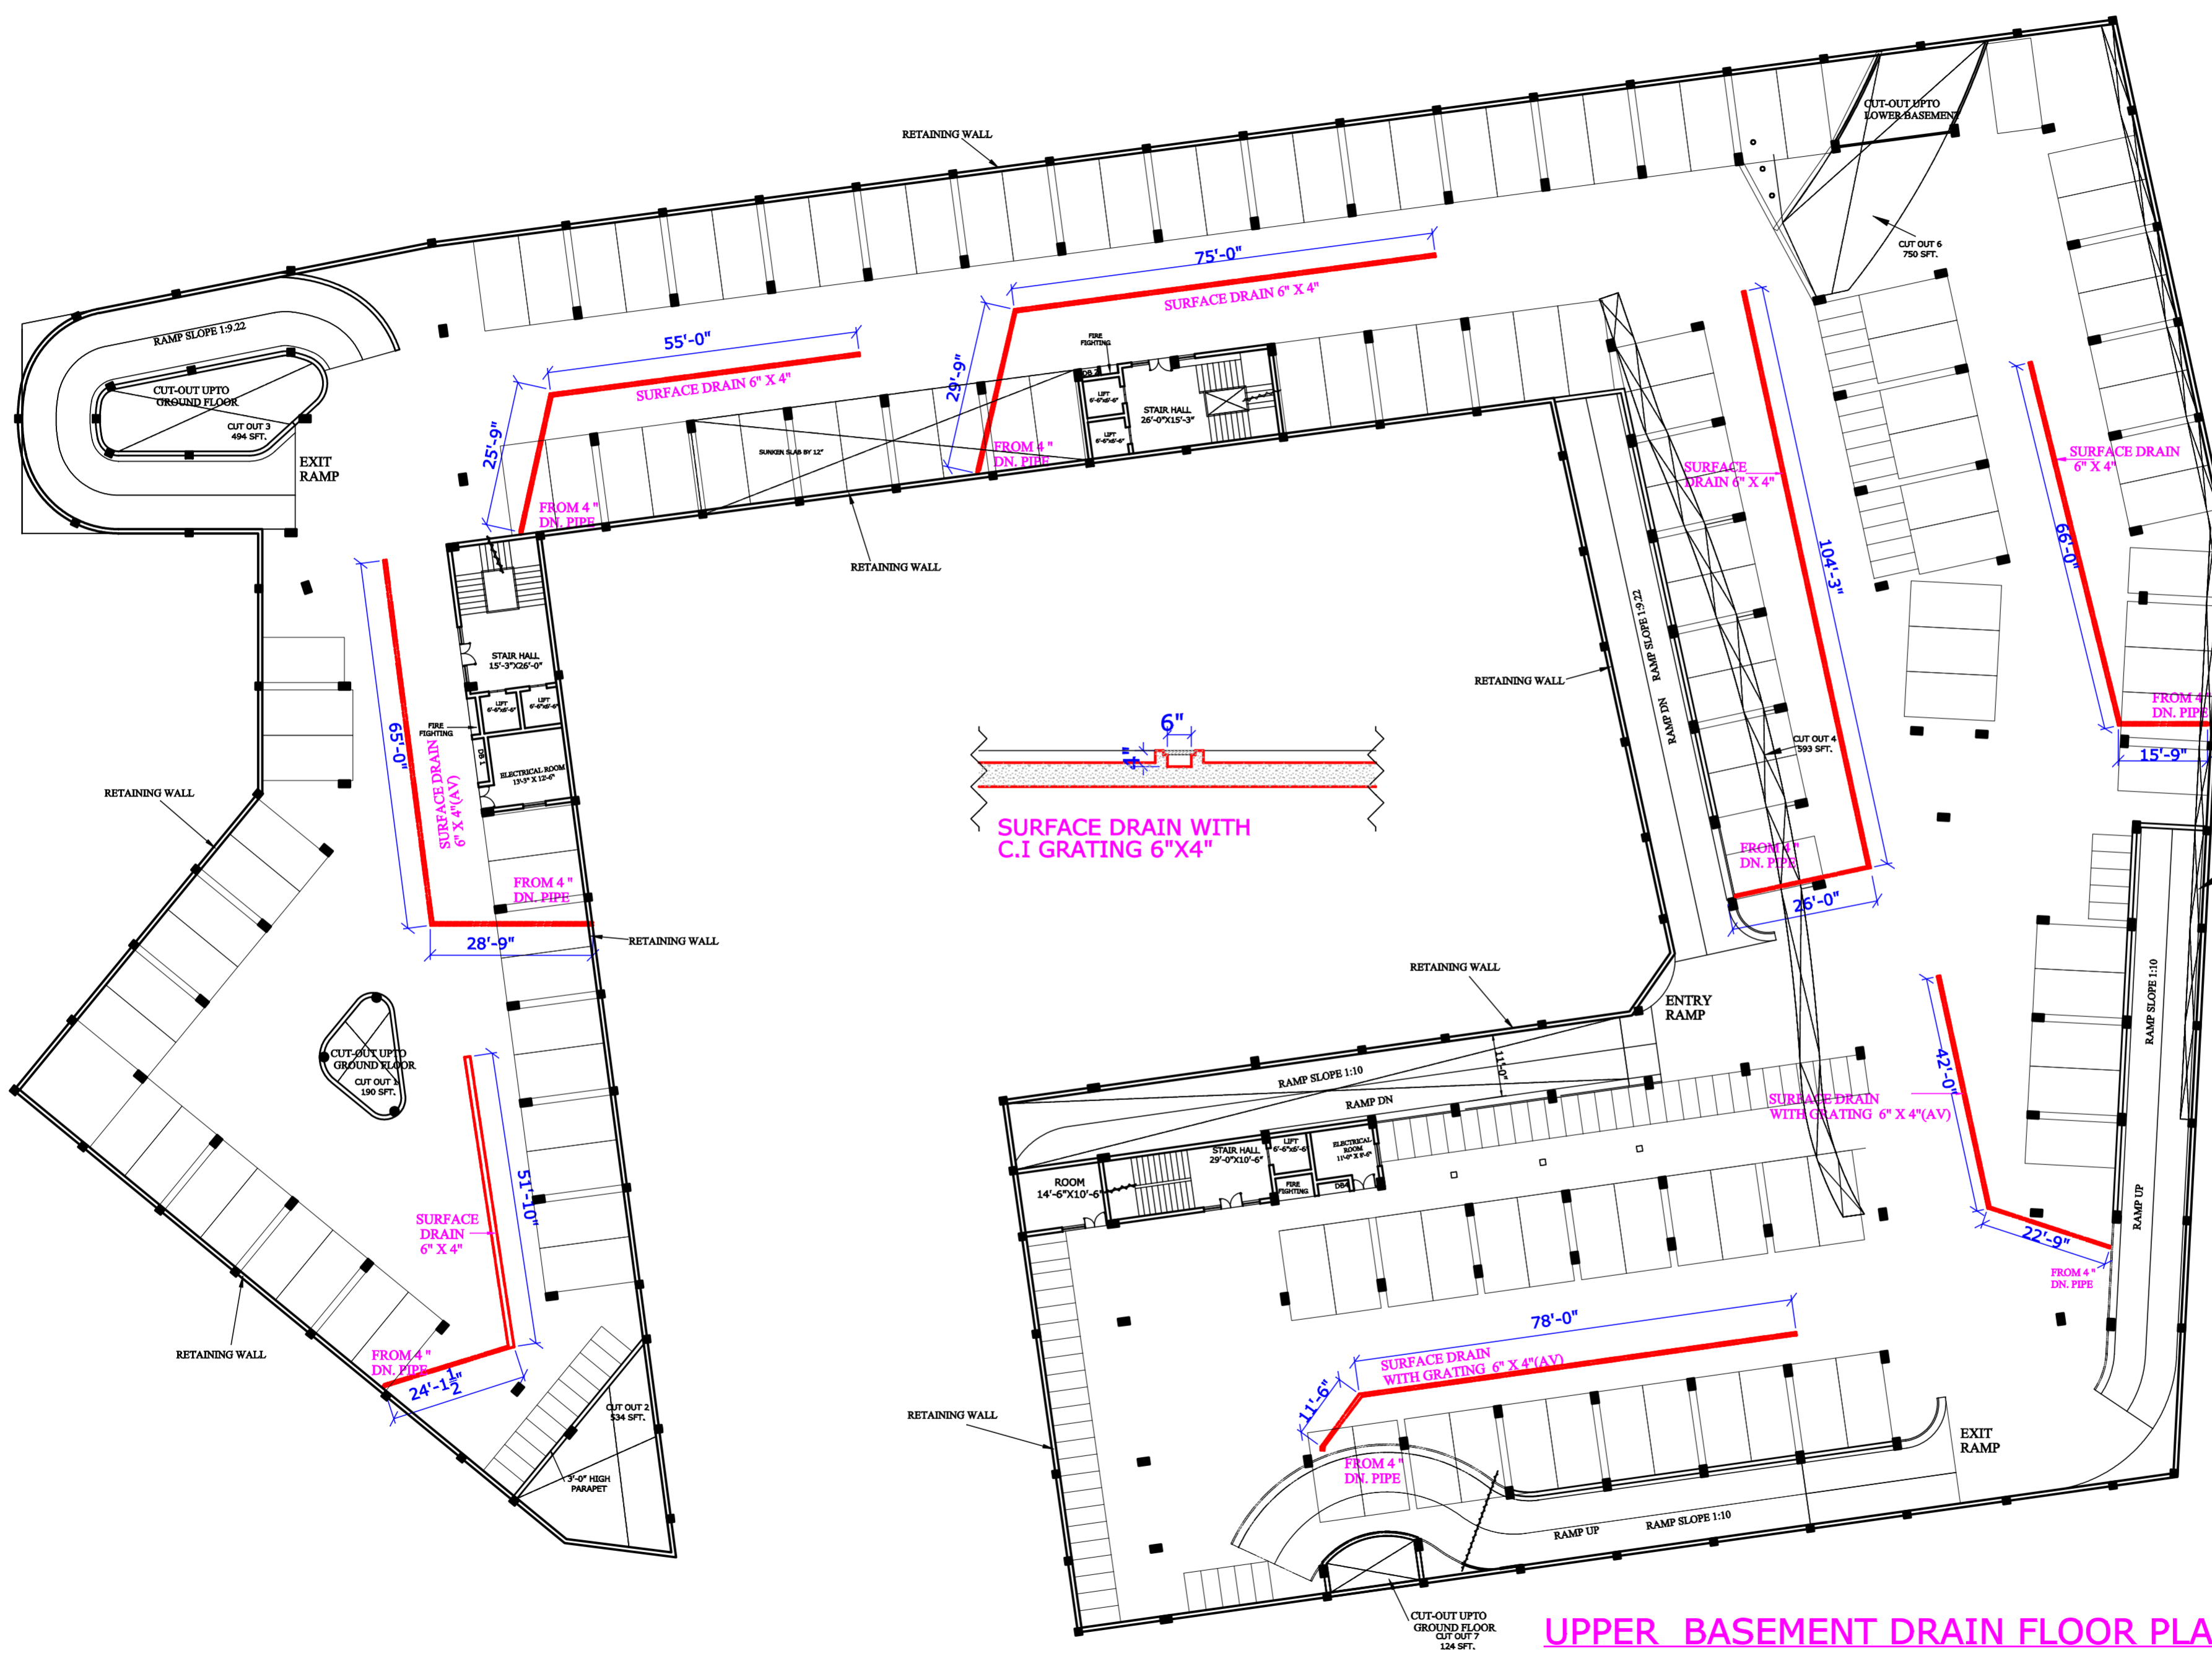

UPPER BASEMENT DRAIN FLOOR PLAN