


**BEAUTIFICATION OF
DURGIANA MANDIR COMPLEX
AMRITSAR
(PROPOSED PARKING)**

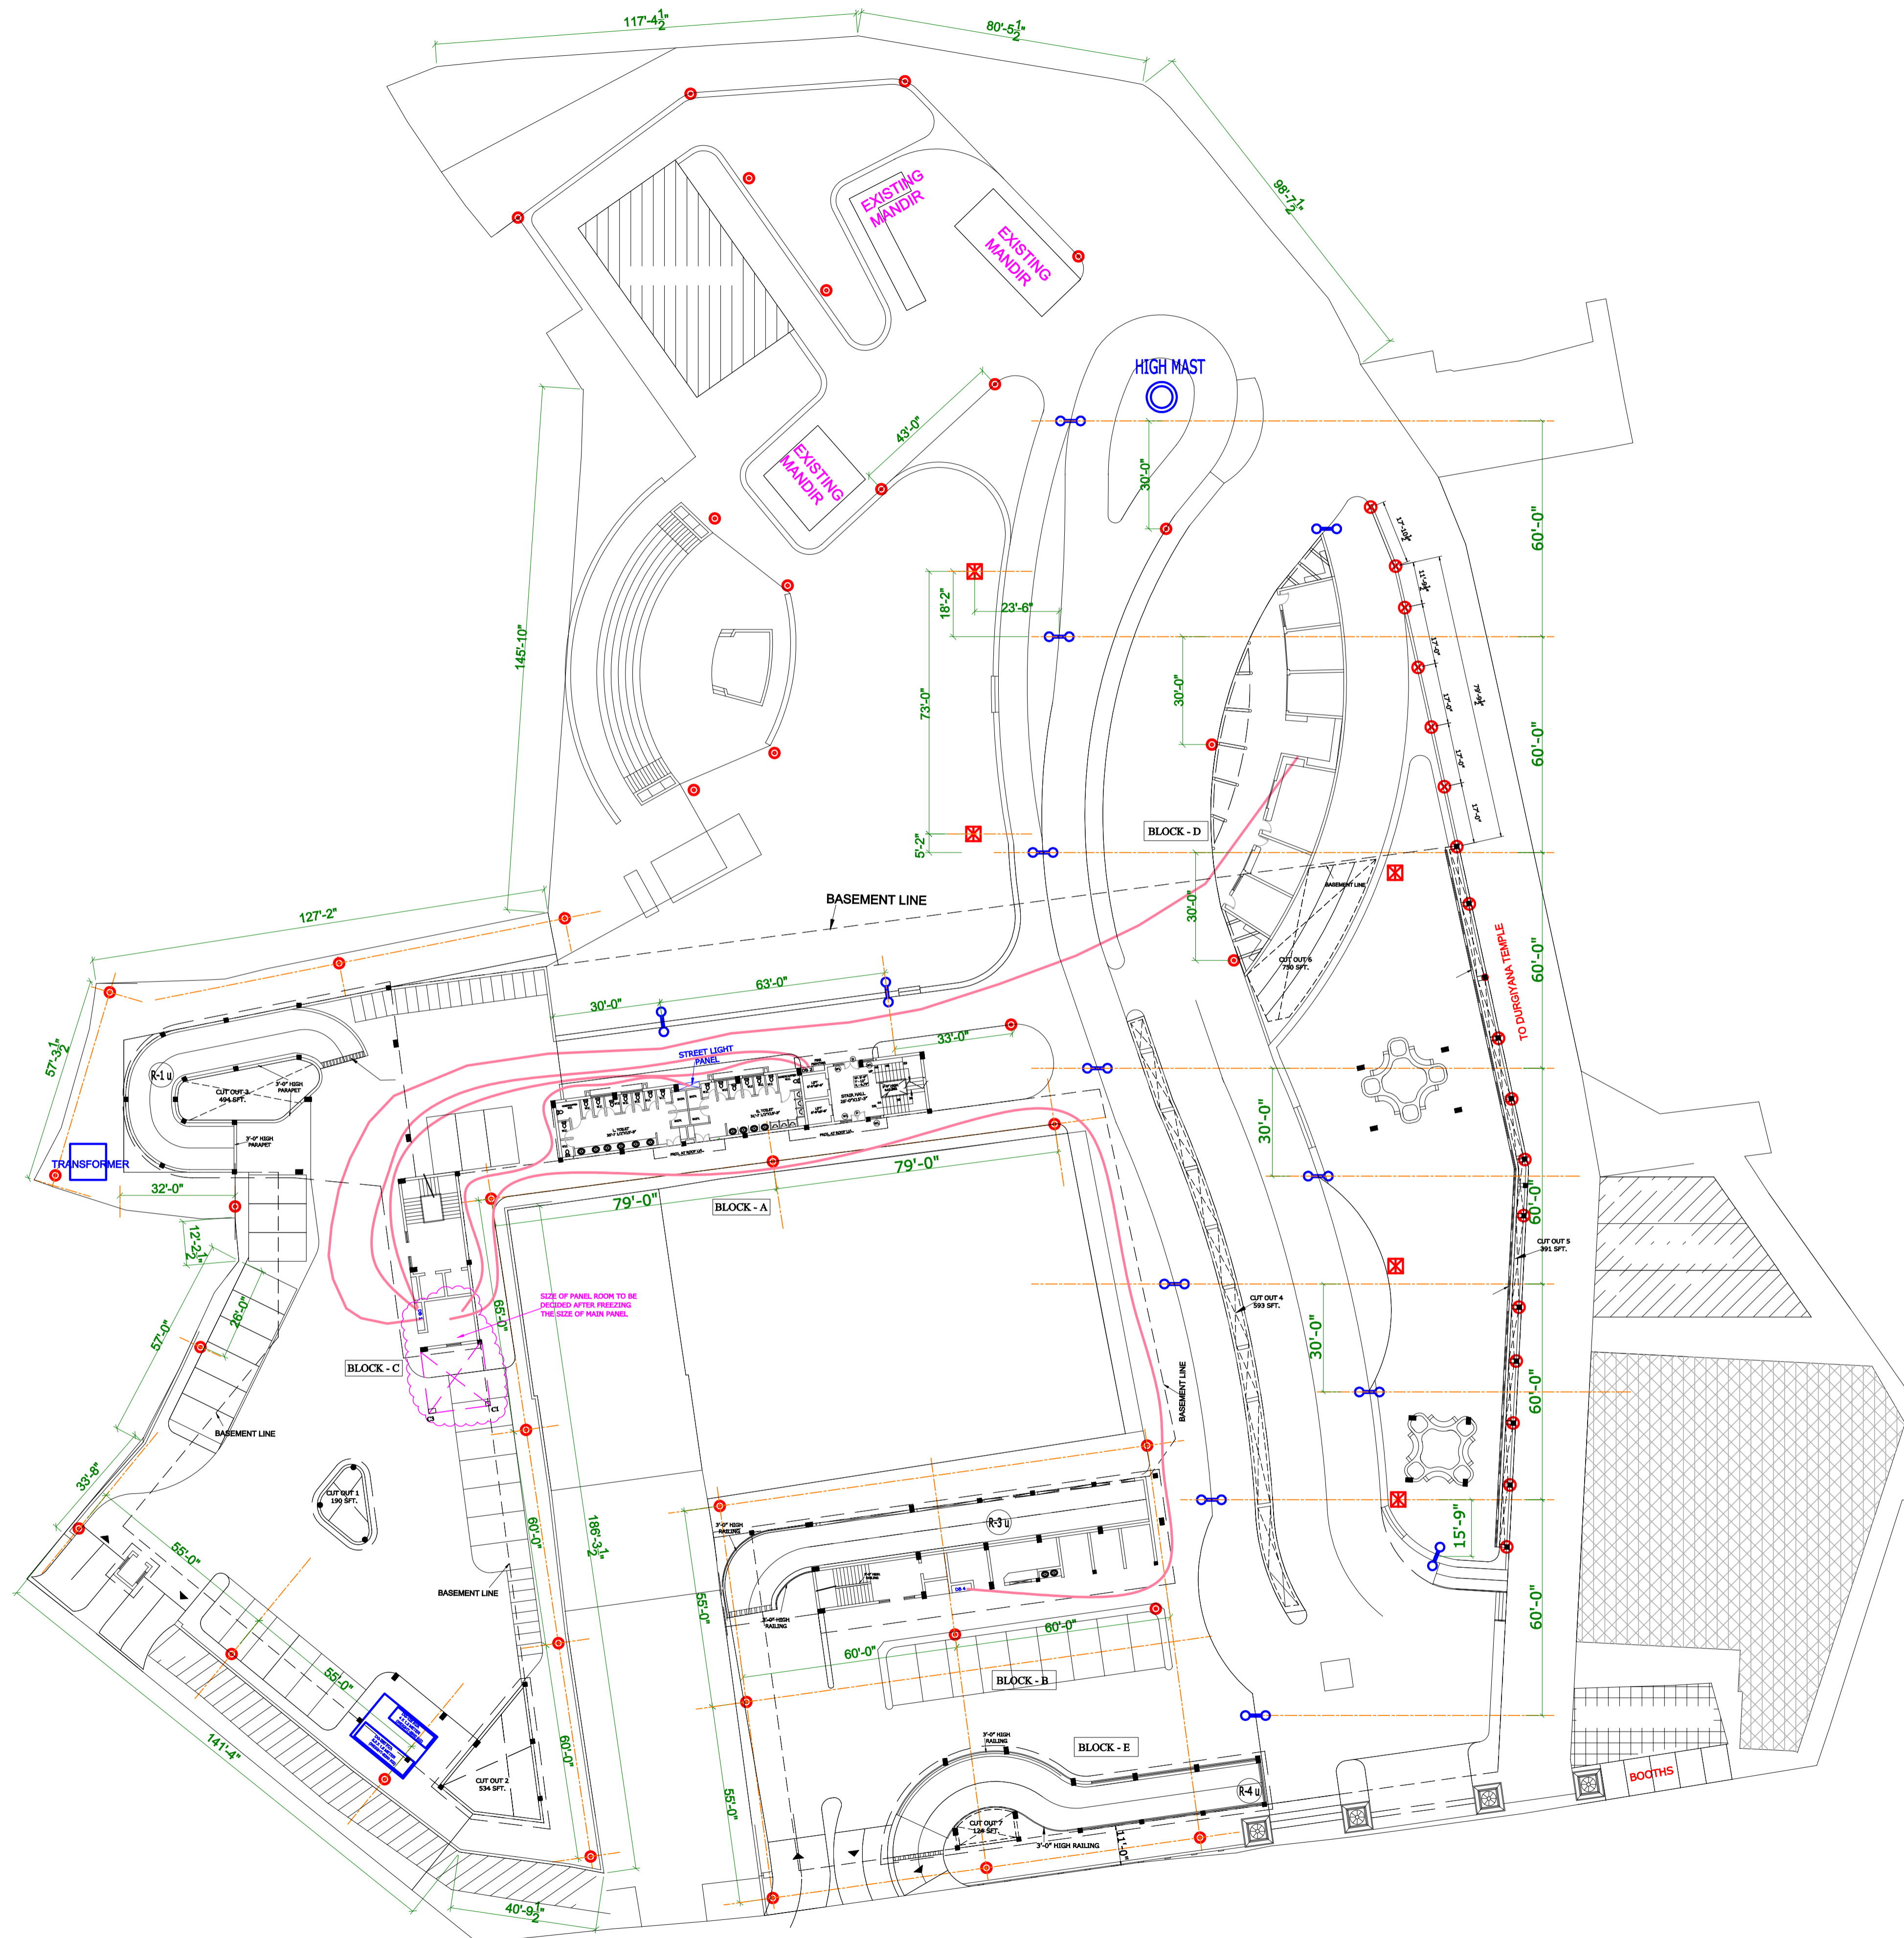

Legend

Sr.No.	Symbol	Description	QTY.
1	⊙	4 MT. GRP Pole with 1x70 w Luminaries Single Arm Bracket	39
2	⊕	4 MT. GRP Pole with 2x70 w Luminaries Double Arm Bracket	21
3	⊗	GI Pipe Bracket 1.5 mt. Long on Boundary Wall with 2X18 watt CFL Light	20
4	⊠	Bollard	5
5	⊞	Street Light Panel	1
6	⊙	HIGH MAST 12.5 MT. WITH 6X2X400 W LUMINARIES	1
7			

OWNER :

ELECTRICAL CONSULTANT:-

BALWINDER SINGH
OFFICE:24/B, INDUSTRIAL AREA, PHASE-II, CHANDIGARH
BRANCH OFFICE:W/2/313, TEACHERS COLONY, HIRA MAHAL, NABHA,
PHONE NO.9872455534, 9501105681

DRAWING TITLE

SITE PLAN	
DRAWING NO. ELP-01	DRAWN BY
PROJ.NO. :- 0967	CHKD. BY
SCALE:	DATE 03.05.2013

ARCHITECTS CONSORTIUM

ARCHITECTS, PLANNERS, ENGINEERS,
INTERIOR & INDUSTRIAL DESIGNERS
S.C.O - 42, PHASE-3B2, MOHALI. (Pb.).
☎ - 0172-5093132; ☎ - 0172-4643132;
☎ - 98154 43132.
E-mail - info@sudvivek.com
Web site :- www.sudvivek.com COPYRIGHT