



**BEAUTIFICATION OF
DURGIANA MANDIR COMPLEX
AMRITSAR
(PROPOSED PARKING)**

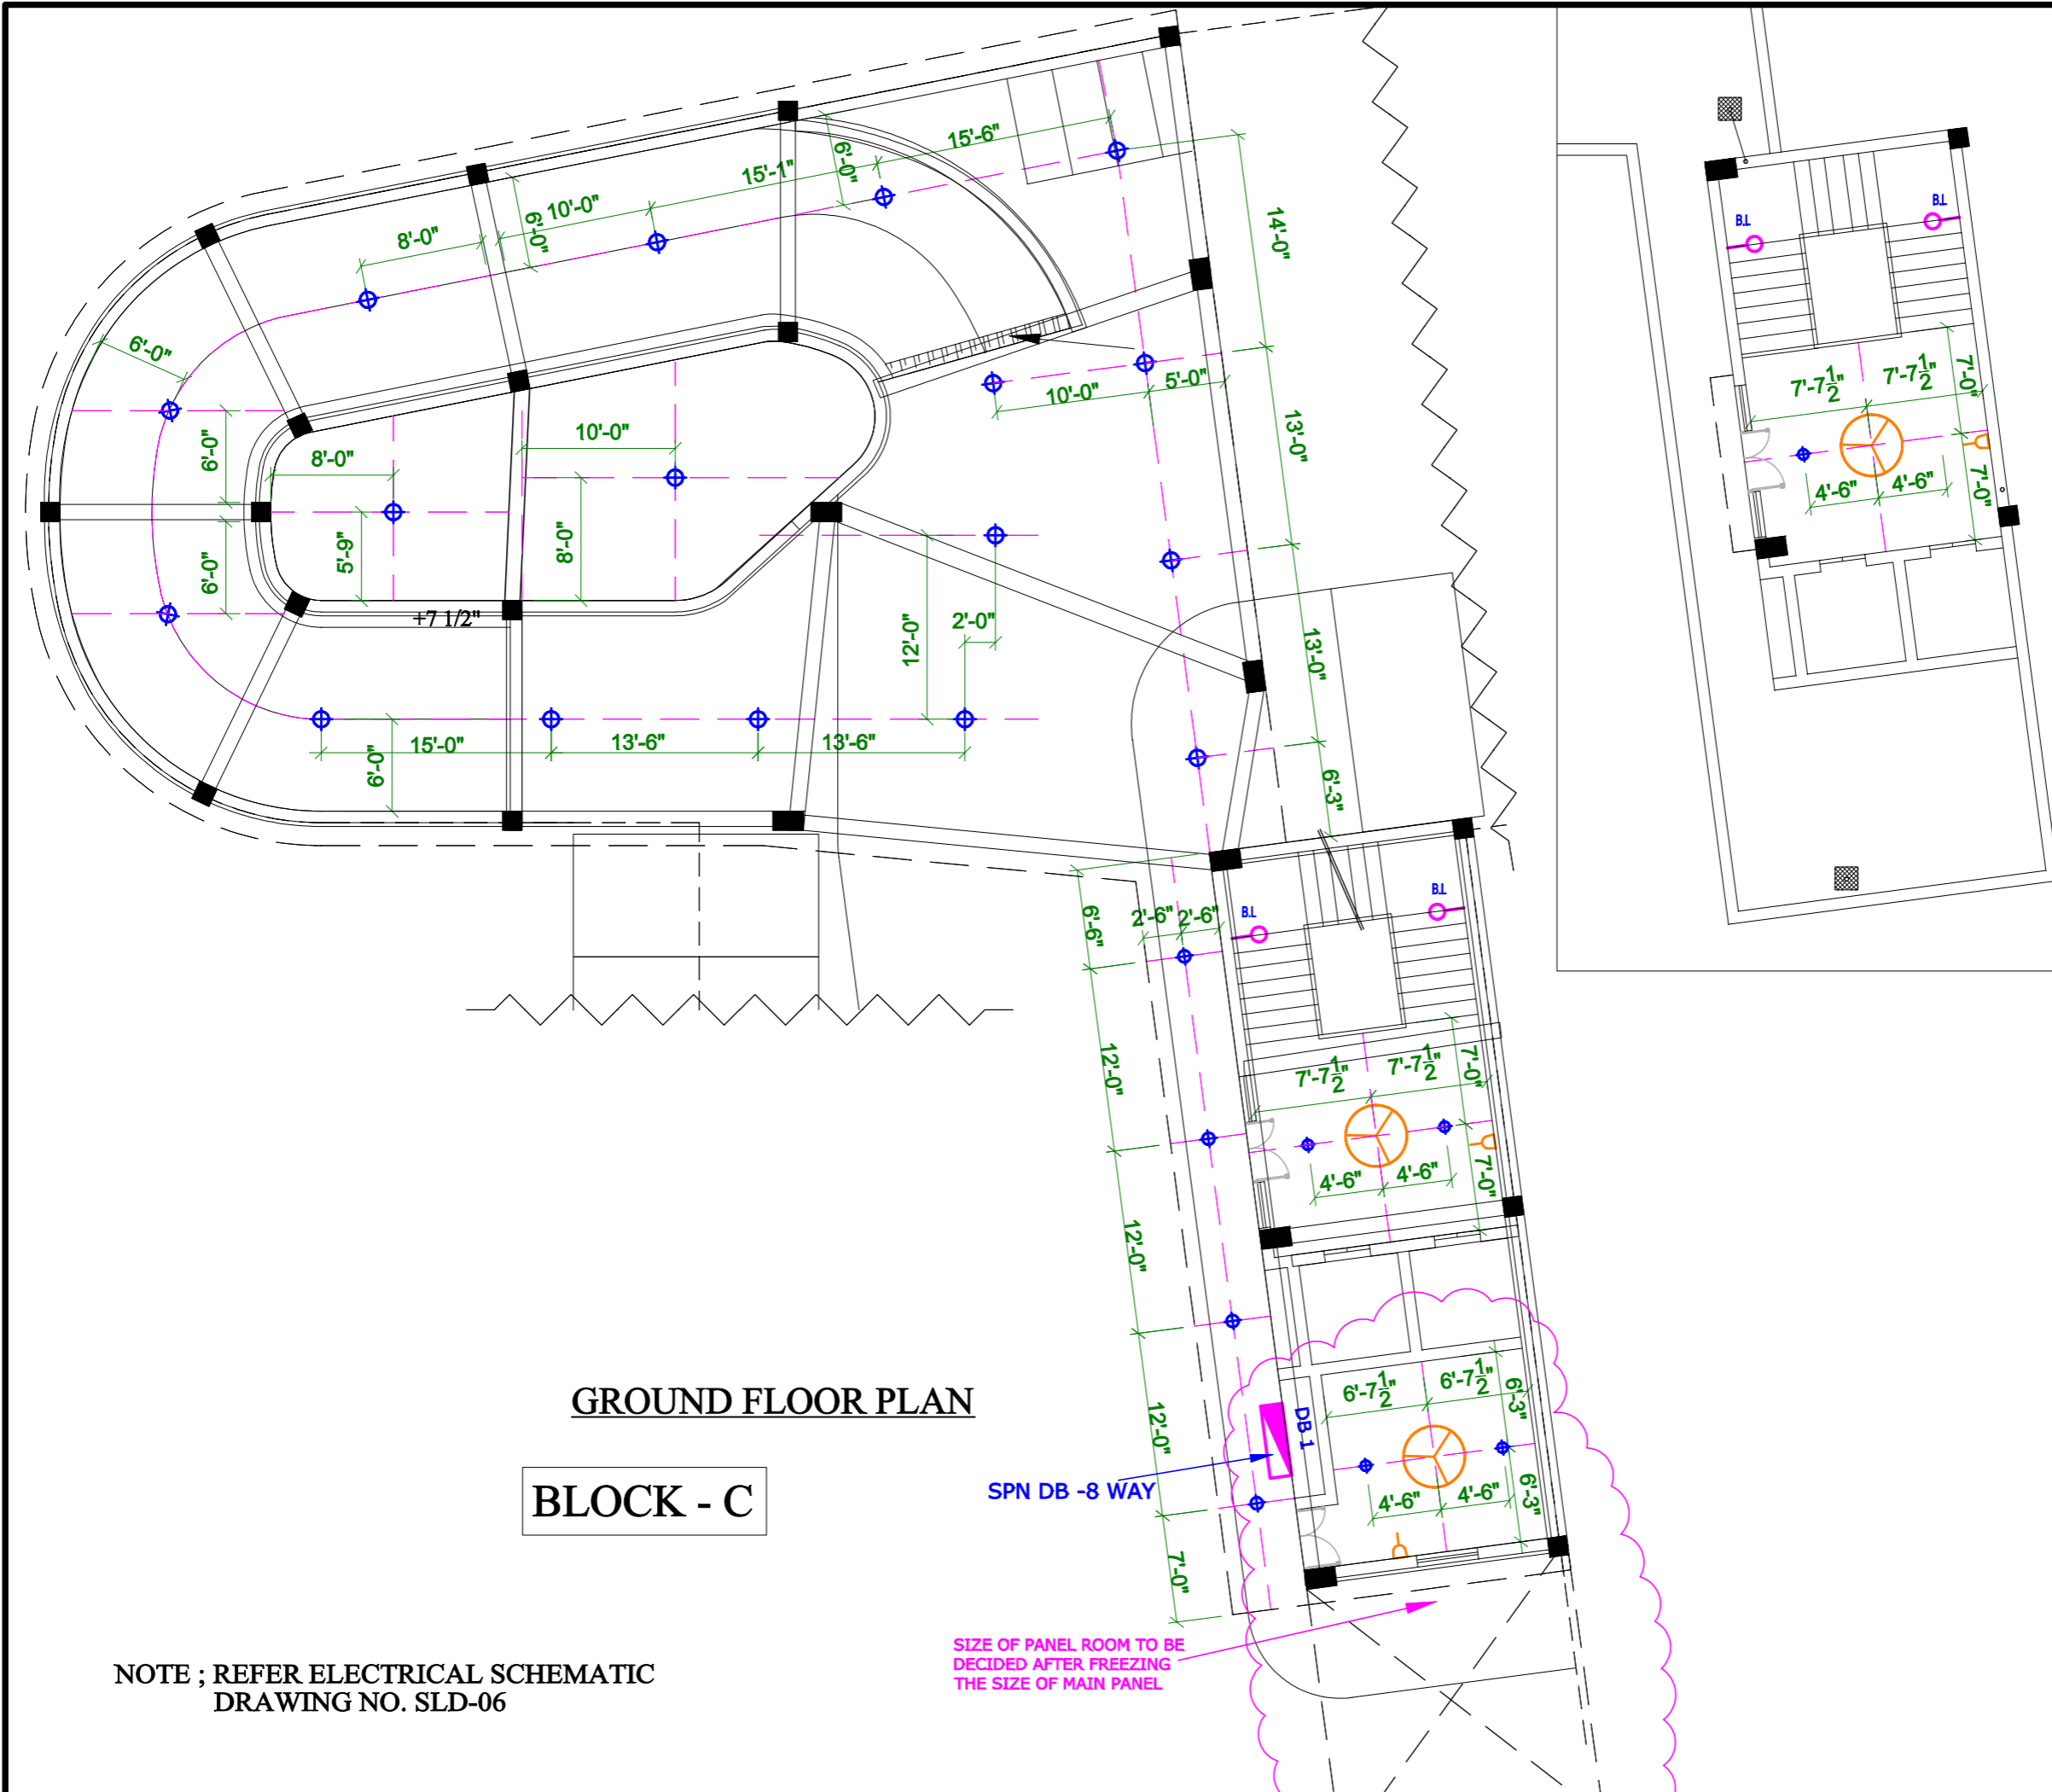

**GROUND FLOOR PLAN
BLOCK - C**

NOTE ; REFER ELECTRICAL SCHEMATIC
DRAWING NO. SLD-06

SIZE OF PANEL ROOM TO BE
DECIDED AFTER FREEZING
THE SIZE OF MAIN PANEL

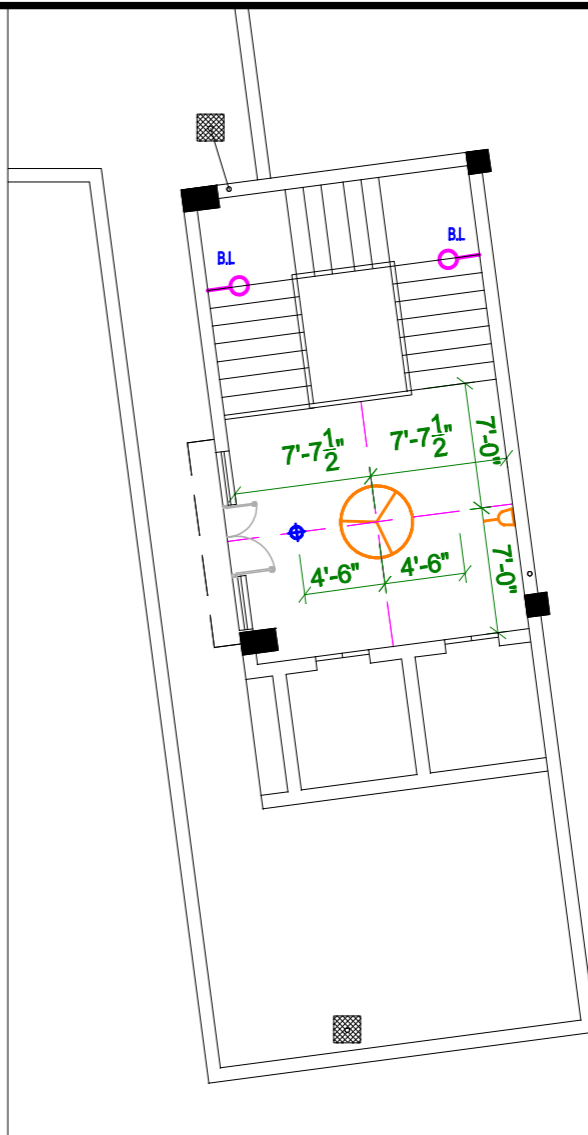

LEGEND

SR.NO.	SYMBOL	NAME	DESCRIPTION
1.		L.D.B	DISTRIBUTION BOARD
2.		—	CEILING FAN
3.		—	CEILING LIGHT POINT
4.		B.L	BRACKET LIGHT
5.		T.L	TUBE LIGHT
6.		SB1	SWITCH BOARD AT 4'-6"
7.		LIGHT SOCKET	6 A SOCKET AT 4'-6"
8.		EF	EXHAUST FAN
9.		PP	16 A POWER SOCKET
10.		METER LOAD SOCKET 20 A	WATER COOLER SOCKET
11.		W.F	WALL FAN

OWNER :

ELECTRICAL CONSULTANT :-

BALWINDER SINGH
OFFICE:248,INDUSTRIAL AREA,PHASE-II,CHANDIGARH
BRANCH OFFICE:W/2513,TEACHERS COLONY,HIRA MAHAL,NABHA.
PHONE NO.8872455534,9601106881

DRAWING TITLE INTERNAL ELECTRIFICATION
DRG. FOR EXIT RAMP
BLOCK - C

DRAWING NO.	ELP 06	DRAWN BY	
PROJ.NO. :-	0967	CHKD. BY	SHARDA PAL
SCALE:	1/16" - 1'-0"	DATE	11.02.13

ARCHITECTS CONSORTIUM

ARCHITECTS, PLANNERS, ENGINEERS,
INTERIOR & INDUSTRIAL DESIGNERS
S.C.O - 42, PHASE-3B2, MOHALI. (Pb.)
☎ - 0172-5093132; 4643132;
☎ - 98154 43132.
E-mail - info@sudvivek.com
Web site :- www.sudvivek.com

© COPYRIGHT